



NOTE: THE INTO RTE 9 SHOULD COMPLY WITH ALL MASS. HIGHWAY SPECIFICATIONS.

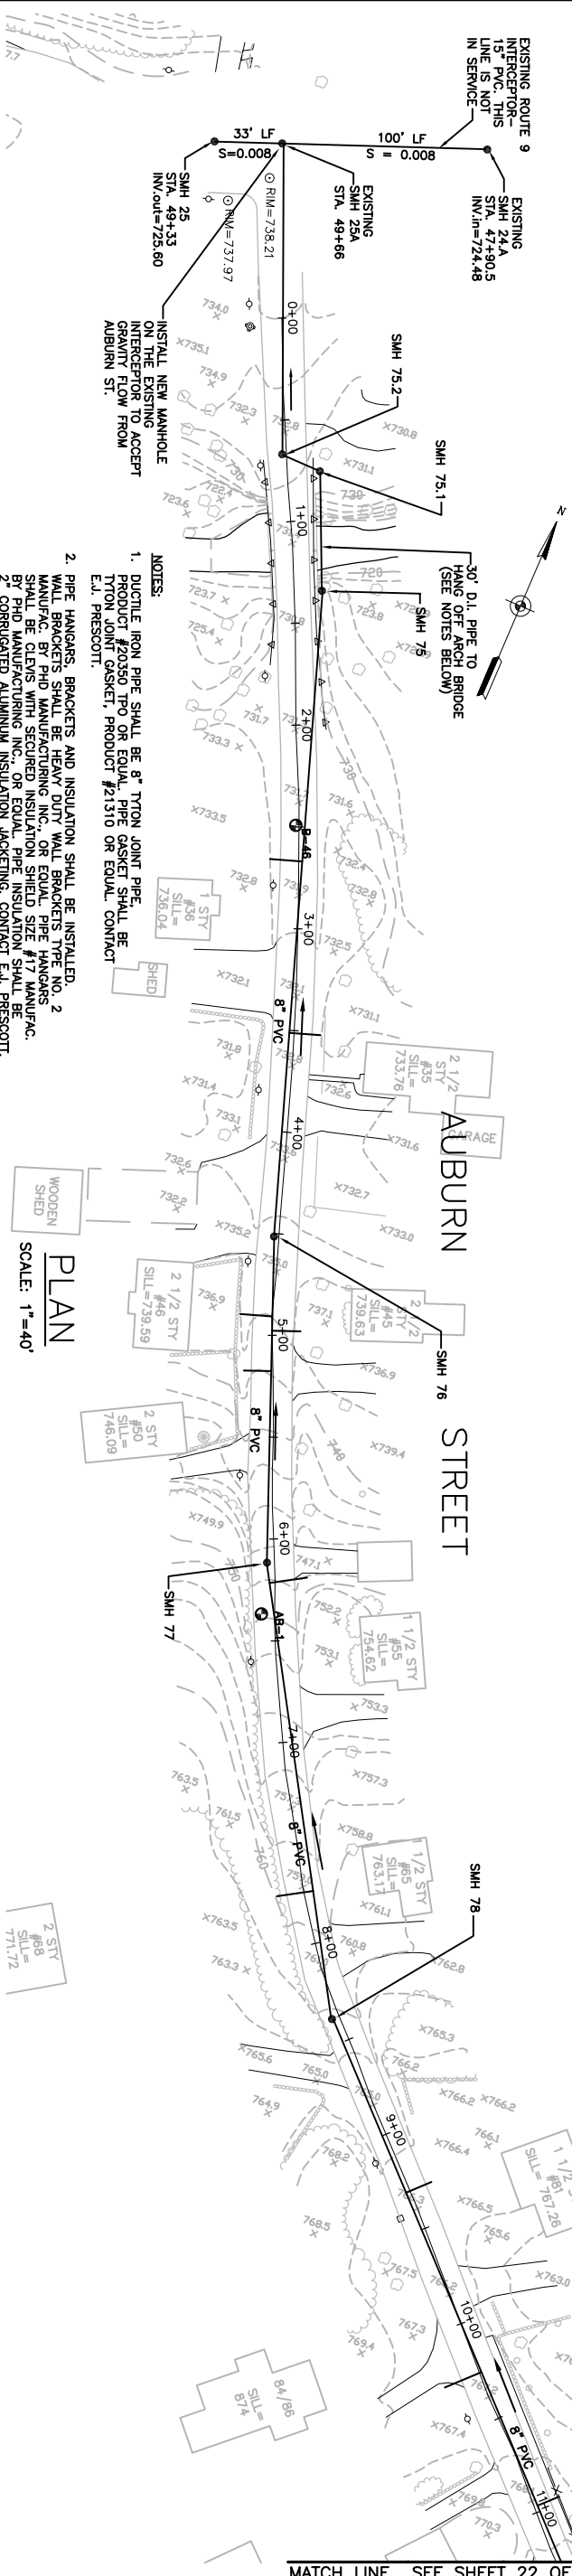

- NOTES:
- DUCTILE IRON PIPE SHALL BE 8" TYTON JOINT PIPE, PRODUCT #20350 TPO OR EQUAL. PIPE GASKET SHALL BE TYTON JOINT GASKET, PRODUCT #21310 OR EQUAL CONTACT E.I. PRESSCOTT.
 - PIPE HANGARS, BRACKETS AND INSULATION SHALL BE INSTALLED. WALL BRACKETS SHALL BE HEAVY DUTY WALL BRACKETS TYPE NO. 2 MANUFAC. BY PHD MANUFACTURING INC. OR EQUAL. PIPE HANGARS SHALL BE CLEVIS WITH SECURED INSULATION SHIELD SIZE #17 MANUFAC. BY PHD MANUFACTURING INC. OR EQUAL. PIPE INSULATION SHALL BE CORRUGATED ALUMINUM INSULATION JACKETING, CONTACT E.I. PRESSCOTT.
 - PIPE SADDLES FOR 2" INSULATION MANUFAC. BY PHD MANUFACTURING INC. FOR 10" PIPE SIZE OR EQUAL SHALL BE USED.

PLAN
SCALE: 1"=40'

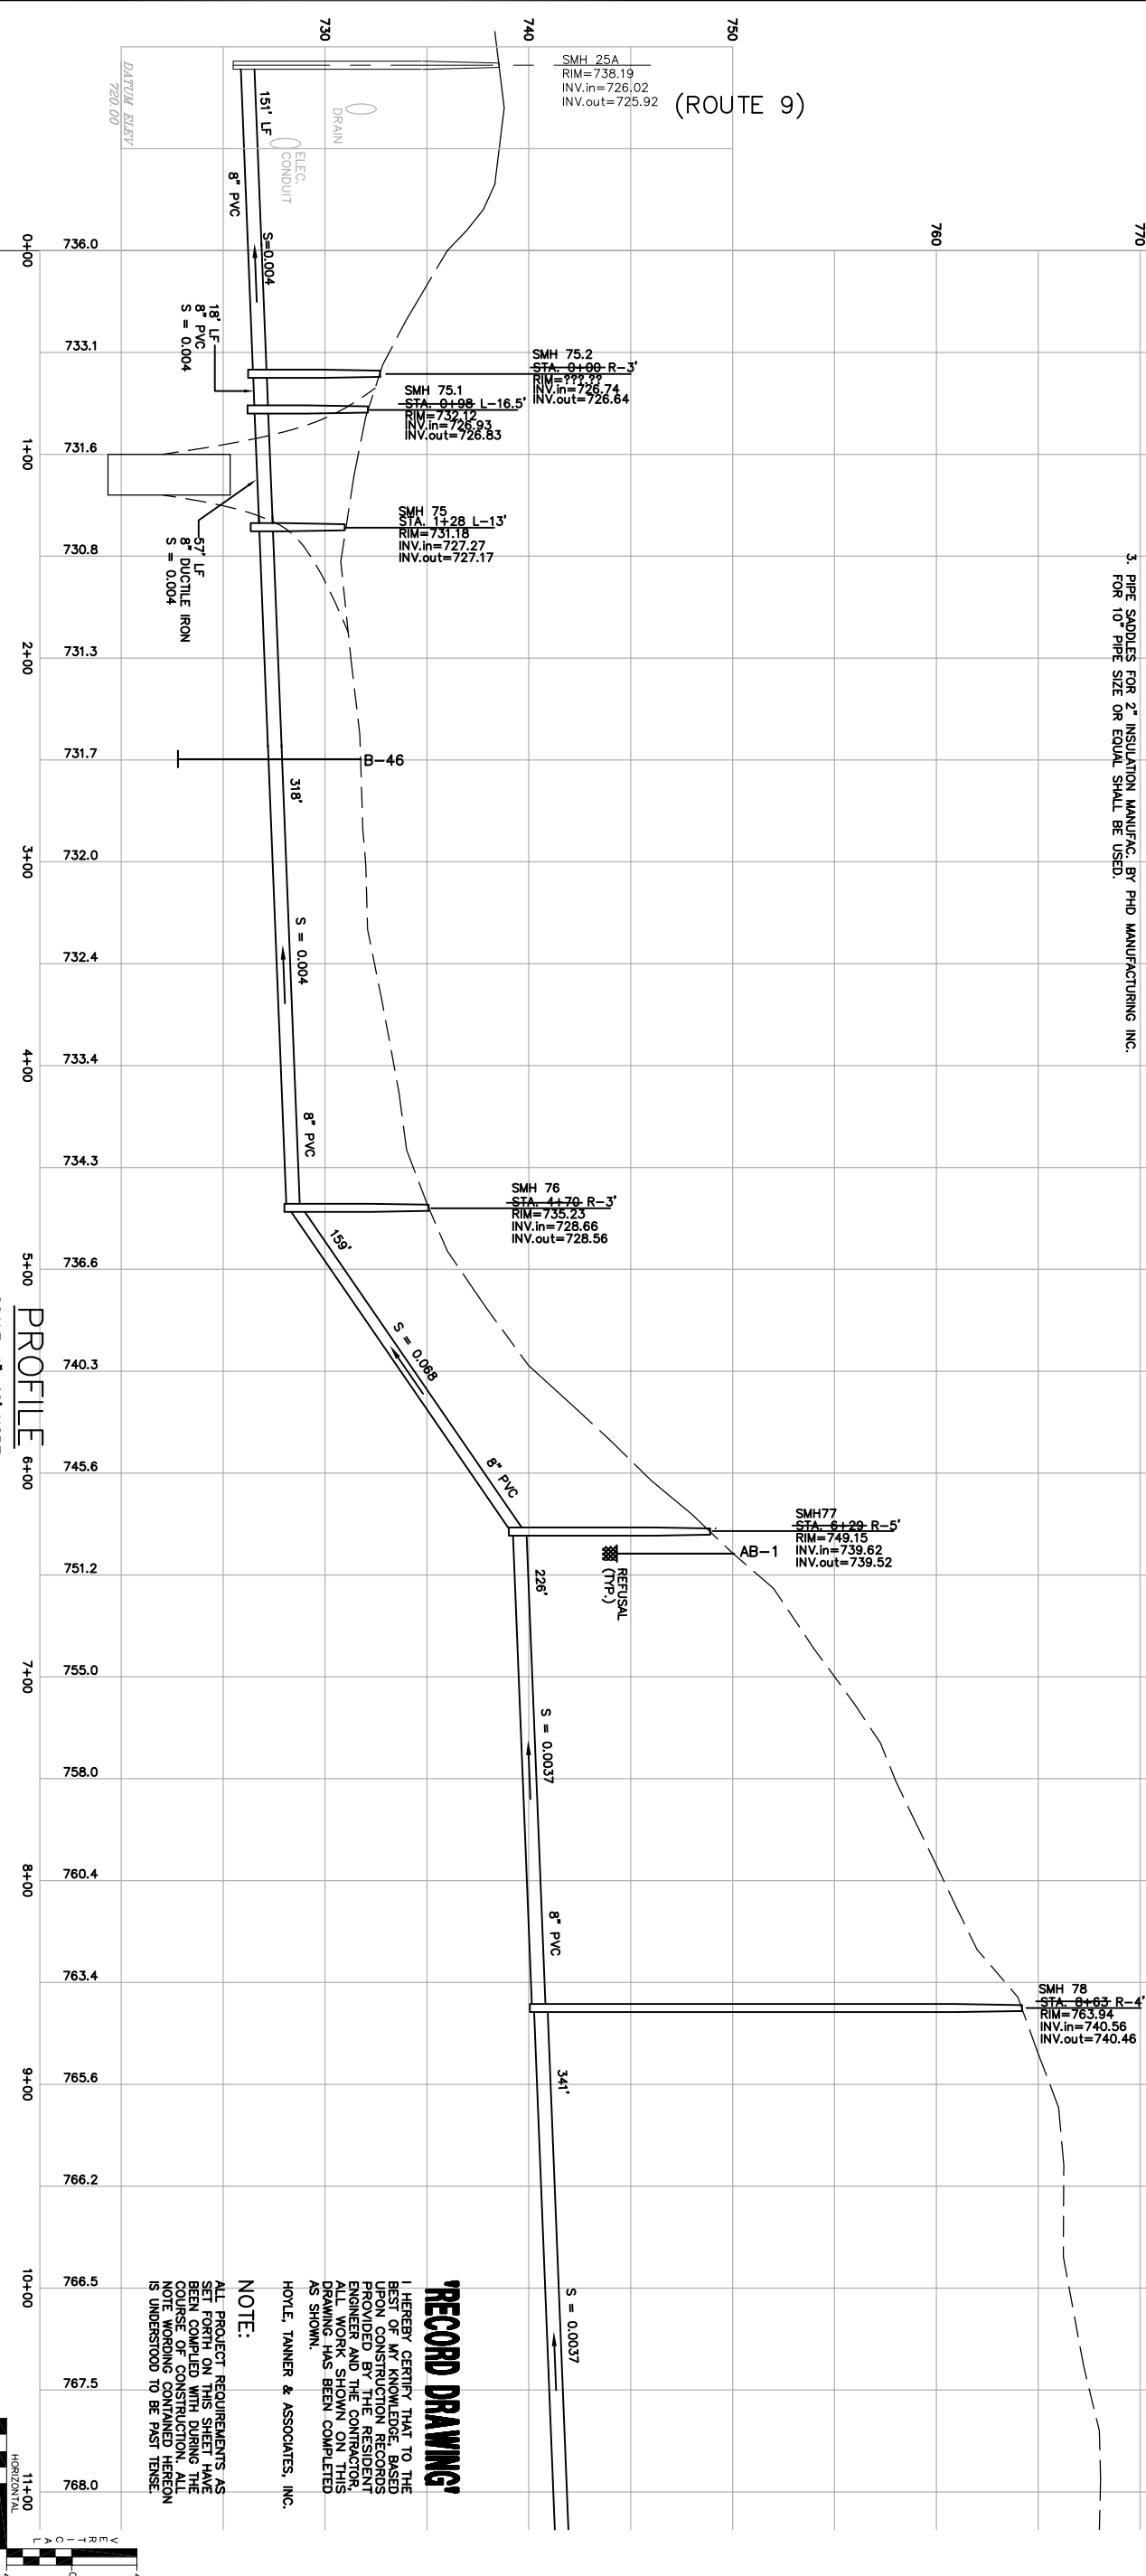

PROFILE
SCALE: 1"=40' HORIZ.
1"=4' VERT.

RECORD DRAWING

I HEREBY CERTIFY THAT TO THE BEST OF MY KNOWLEDGE, BASED UPON CONSTRUCTION RECORDS PROVIDED BY THE RESIDENT, ENGINEER AND THE CONTRACTOR, ALL WORK SHOWN ON THIS DRAWING HAS BEEN COMPLETED AS SHOWN.

HOYLE, TANNER & ASSOCIATES, INC.

NOTE:
ALL PROJECT REQUIREMENTS AS SET FORTH IN THE SPECIFICATIONS HAVE BEEN COMPLIED WITH DURING THE COURSE OF CONSTRUCTION. ALL NOTE WORDING CONTAINED HEREON IS UNDERSTOOD TO BE PAST TENSE.

MATCH LINE SEE SHEET 22 OF 38

DRAWING NO. 21	CHERRY VALLEY SEWER DISTRICT LEICESTER, MASSACHUSETTS		Hoyle, Tanner & Associates, Inc. 150 Dow Street • Manchester • New Hampshire 03101 Consulting Engineers		PROJECT NO. 105709	ENGINEER/ARCHITECT
	PLAN AND PROFILE AUBURN STREET STA. 0+00 TO 11+00		SCALE: AS SHOWN	DATE: APRIL 2001	FILE NAME ABPROF-21	
SHEET 21 OF 38			DES. BY JAH	DR. BY CAB/RCP	CHKD. BY NLT	DO NOT SCALE DRAWING
				1. RECORD DRAWING C.B. W.C. W.C. 10/02		DR. BY CHKD. BY APPD. BY DATE