




PLAN
SCALE: 1"=40'

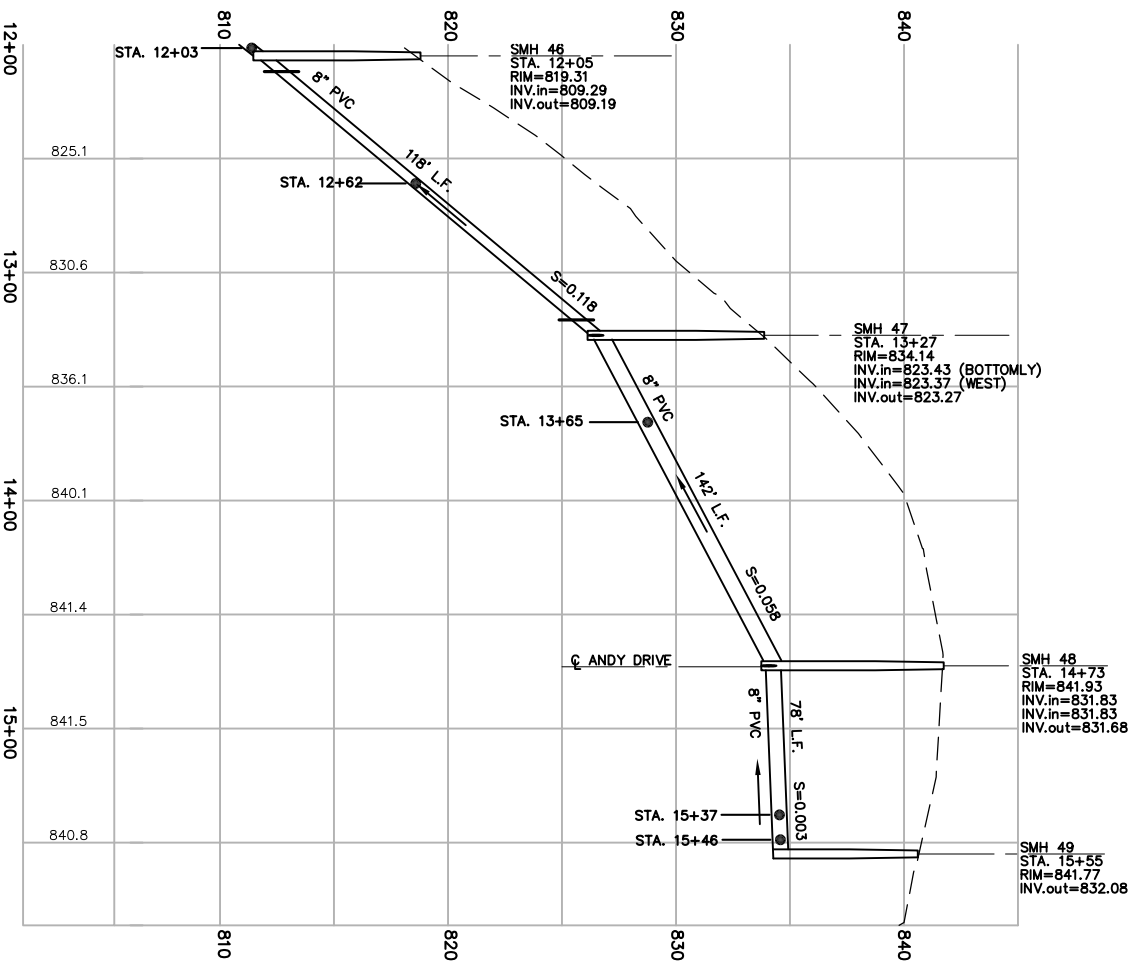

PROFILE
SCALE: 1"=40' HORIZ.
1"=4' VERT.

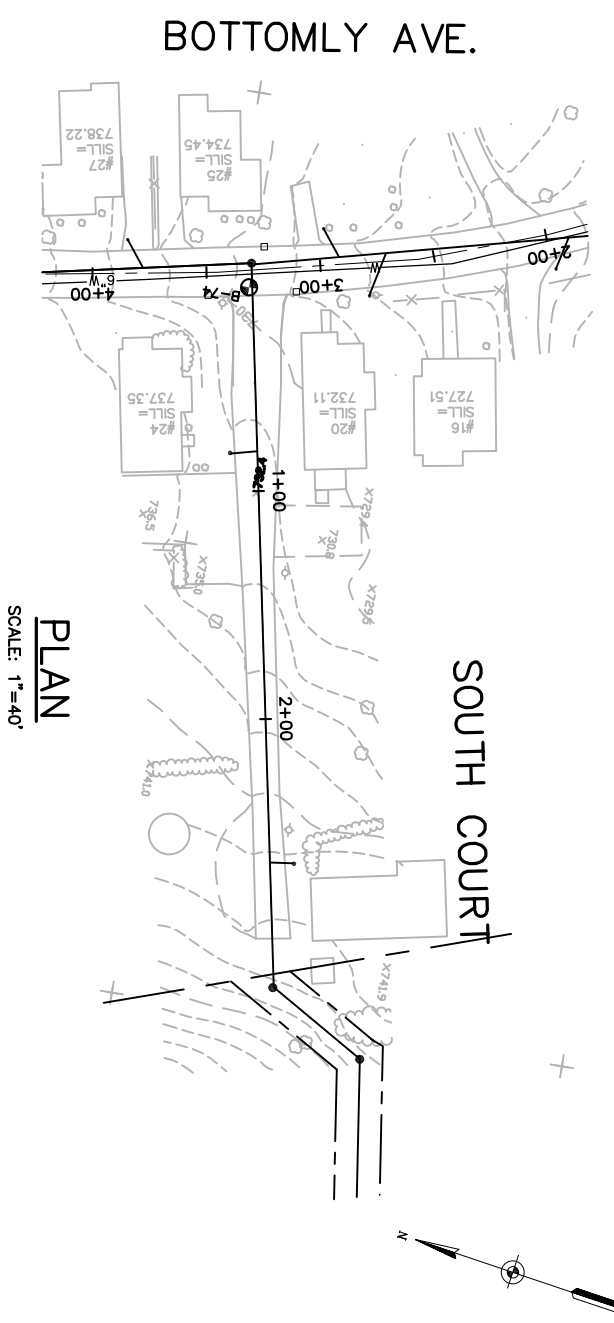


PLAN
SCALE: 1"=40'

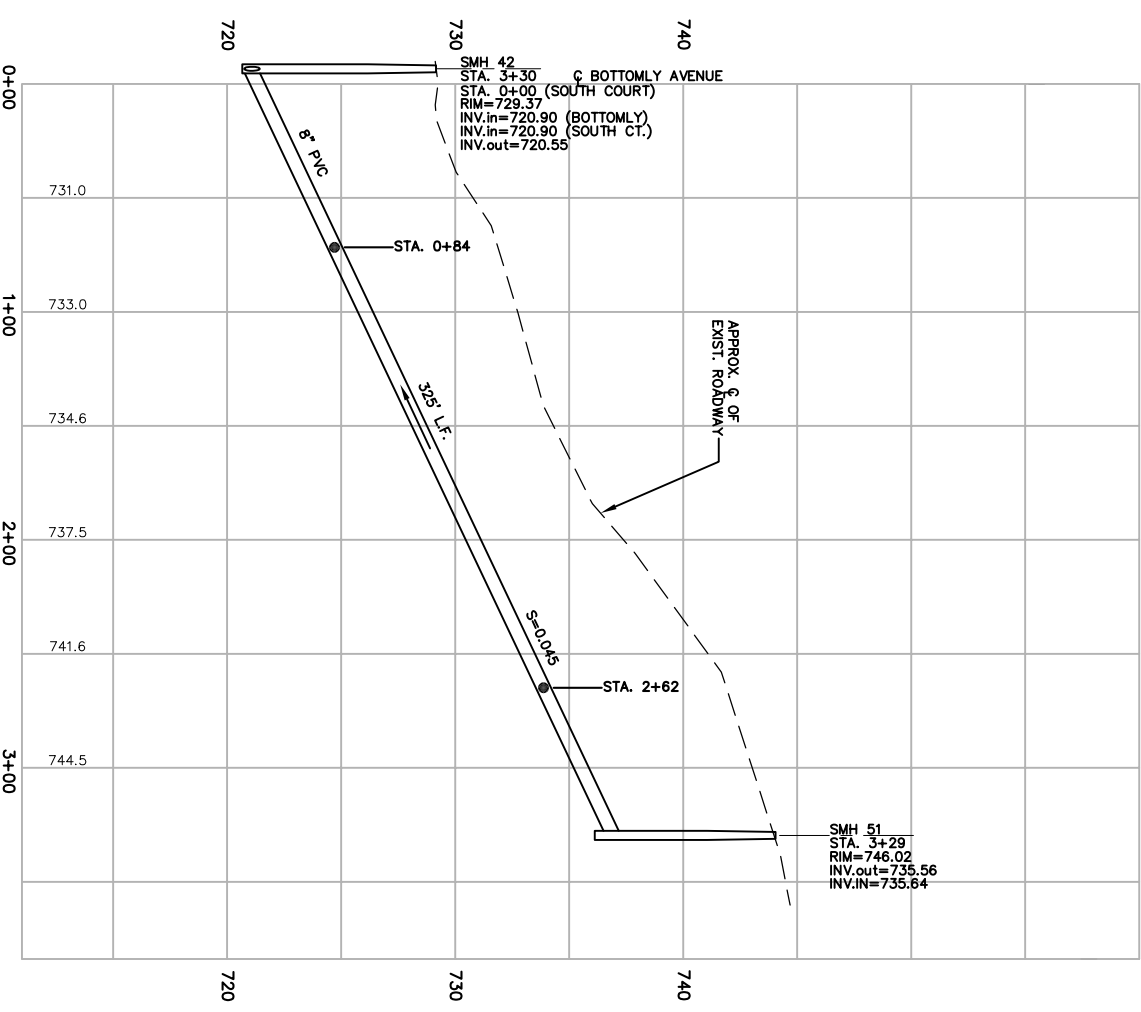

PROFILE
SCALE: 1"=40' HORIZ.
1"=4' VERT.

"AS-BUILT"
I HEREBY CERTIFY THAT TO THE BEST OF MY KNOWLEDGE AND BELIEF, THE INFORMATION AND DATA PROVIDED BY THE RESIDENT ENGINEER AND THE CONTRACTOR, ALL WORK SHOWN ON THIS DRAWING HAS BEEN COMPLETED AS SHOWN.
HOYLE, TANNER & ASSOCIATES, INC.
SIGNED _____
DATE _____

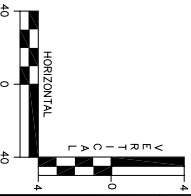

DRAWING NO. 12	CHERRY VALLEY SEWER DISTRICT LEICESTER, MASSACHUSETTS PLAN AND PROFILE		Hoyle, Tanner & Associates, Inc. 150 Dow Street • Manchester • New Hampshire 03101 Consulting Engineers	PROJECT NO. 105707	1. AS-BUILTS C.B. J.H. J.H. 12/00 DR. BY: CHD. BY: APPD. BY: DATE	
	BOTTOMLY AVE. / SOUTH CT. 12+00 TO 15+86 / 0+00 TO 2+90			FILE NAME AB105P11		DO NOT SCALE DRAWING
SHEET 12 OF 18	SCALE: AS SHOWN	DATE: APRIL 2000	DES. BY JAH	DR. BY RCP	CHKD. BY NLT	ENGINEER/ARCHITECT