



**PLAN**  
SCALE: 1"=40'

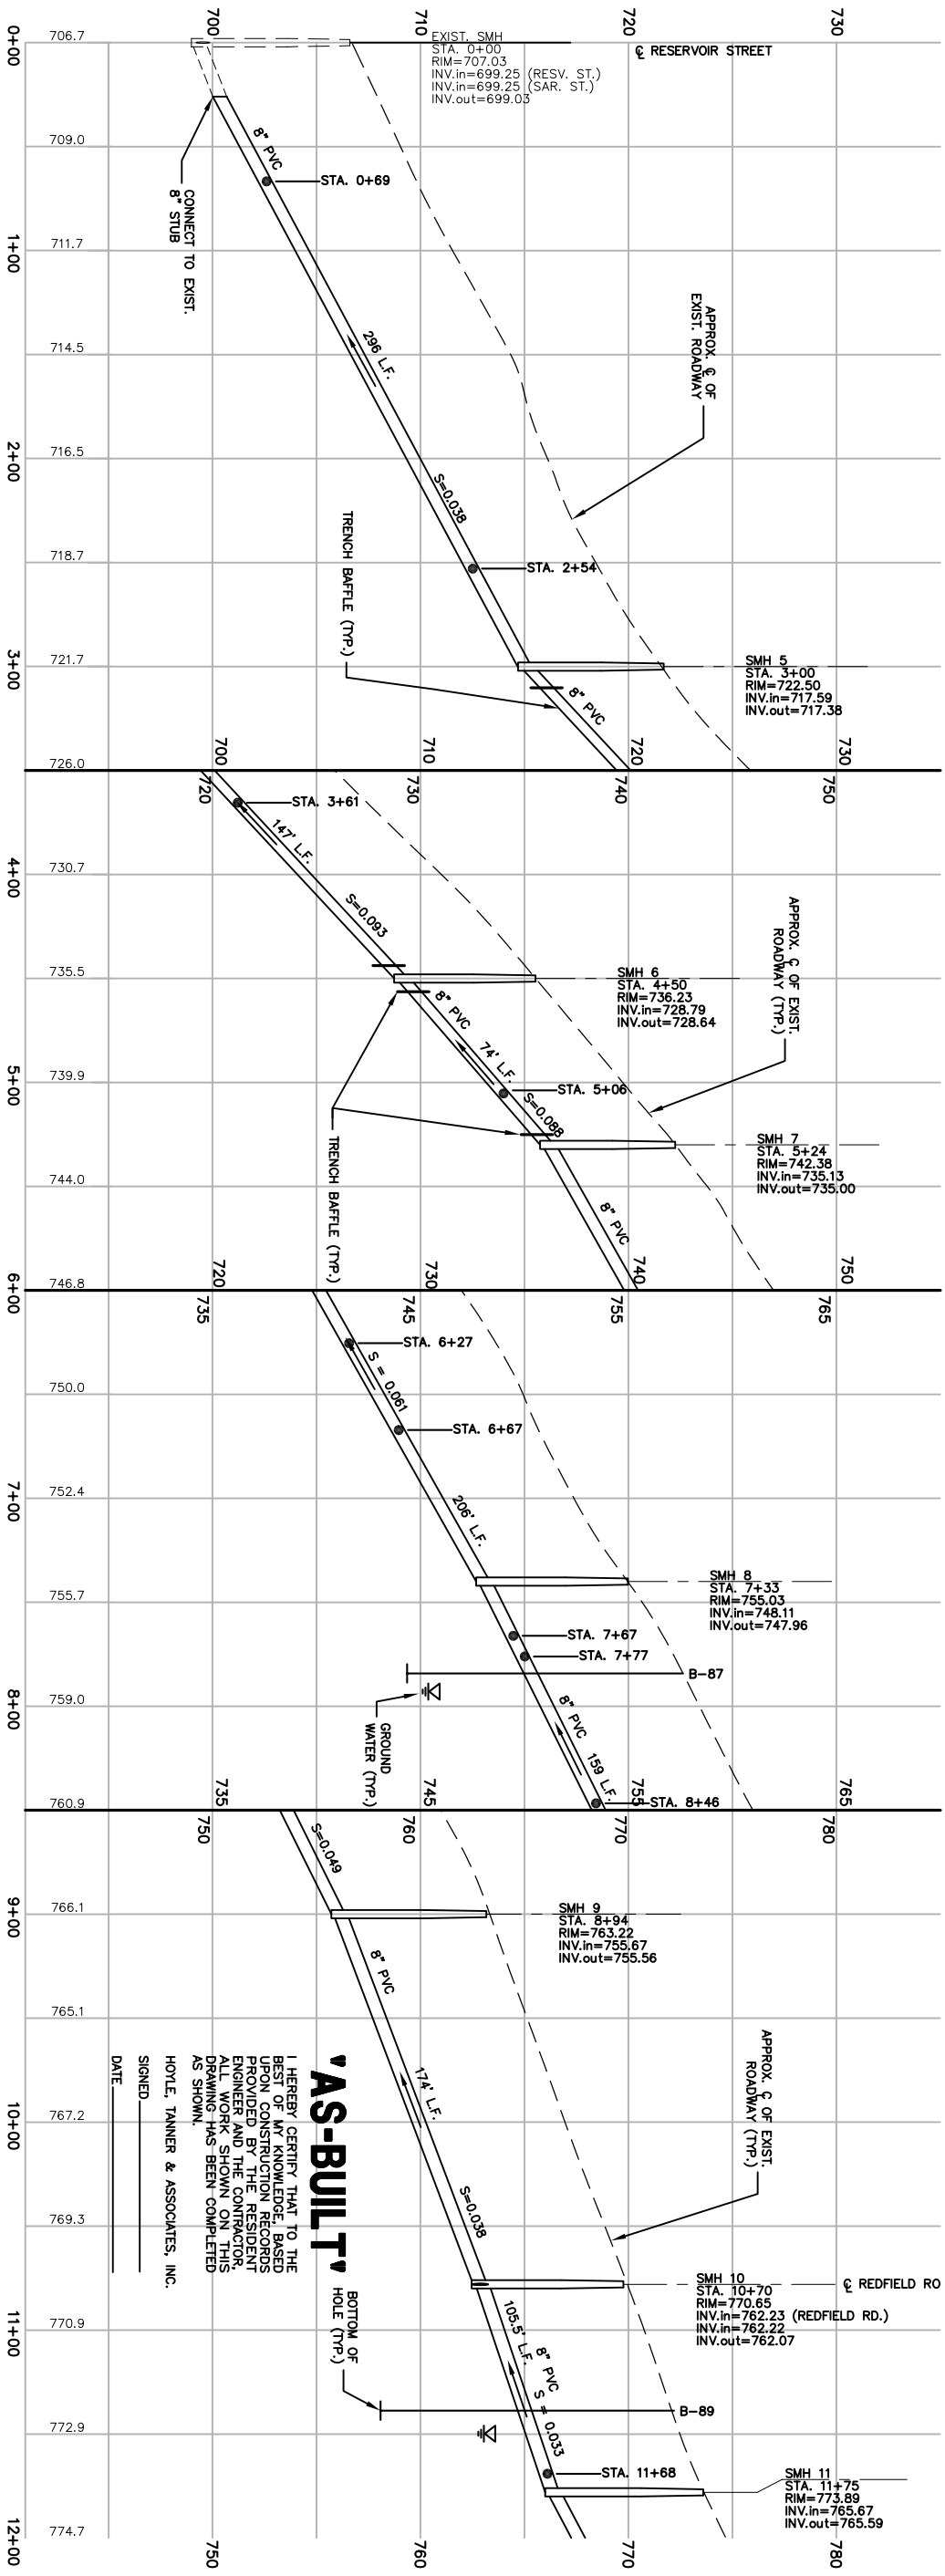

**PROFILE**  
SCALE: 1"=40' HORZ.  
1"=4' VERT.

**'AS-BUILT'**

I HEREBY CERTIFY THAT TO THE BEST OF MY KNOWLEDGE, BASED UPON THE RECORD DRAWINGS PROVIDED BY THE DESIGNER, ENGINEER AND THE CONTRACTOR, ALL WORK SHOWN ON THIS DRAWING HAS BEEN COMPLETED AS SHOWN.  
HOYLE, TANNER & ASSOCIATES, INC.  
SIGNED \_\_\_\_\_  
DATE \_\_\_\_\_

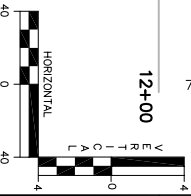

SHEET <b>3</b> OF 18	DRAWING NO. <b>3</b>	CHERRY VALLEY SEWER DISTRICT LEICESTER, MASSACHUSETTS PLAN AND PROFILE	<b>HTA</b> Hoyle, Tanner & Associates, Inc. 150 Dow Street • Manchester • New Hampshire 03101 Consulting Engineers	PROJECT NO. 105707	ENGINEER/ARCHITECT
		<b>SARGENT STREET</b> 0+00 TO 12+00		FILE NAME AB105P01	
SCALE: AS SHOWN	DATE: APRIL 2000	DES. BY JAH	DR. BY RCP	CHKD. BY NLT	DO NOT SCALE DRAWING
		1. AS-BUILTS REV. DESCRIPTION		C.B. J.H. J.H. 10/00 DR. CHD. APPD. BY DATE	