



PLAN
SCALE: 1"=40'

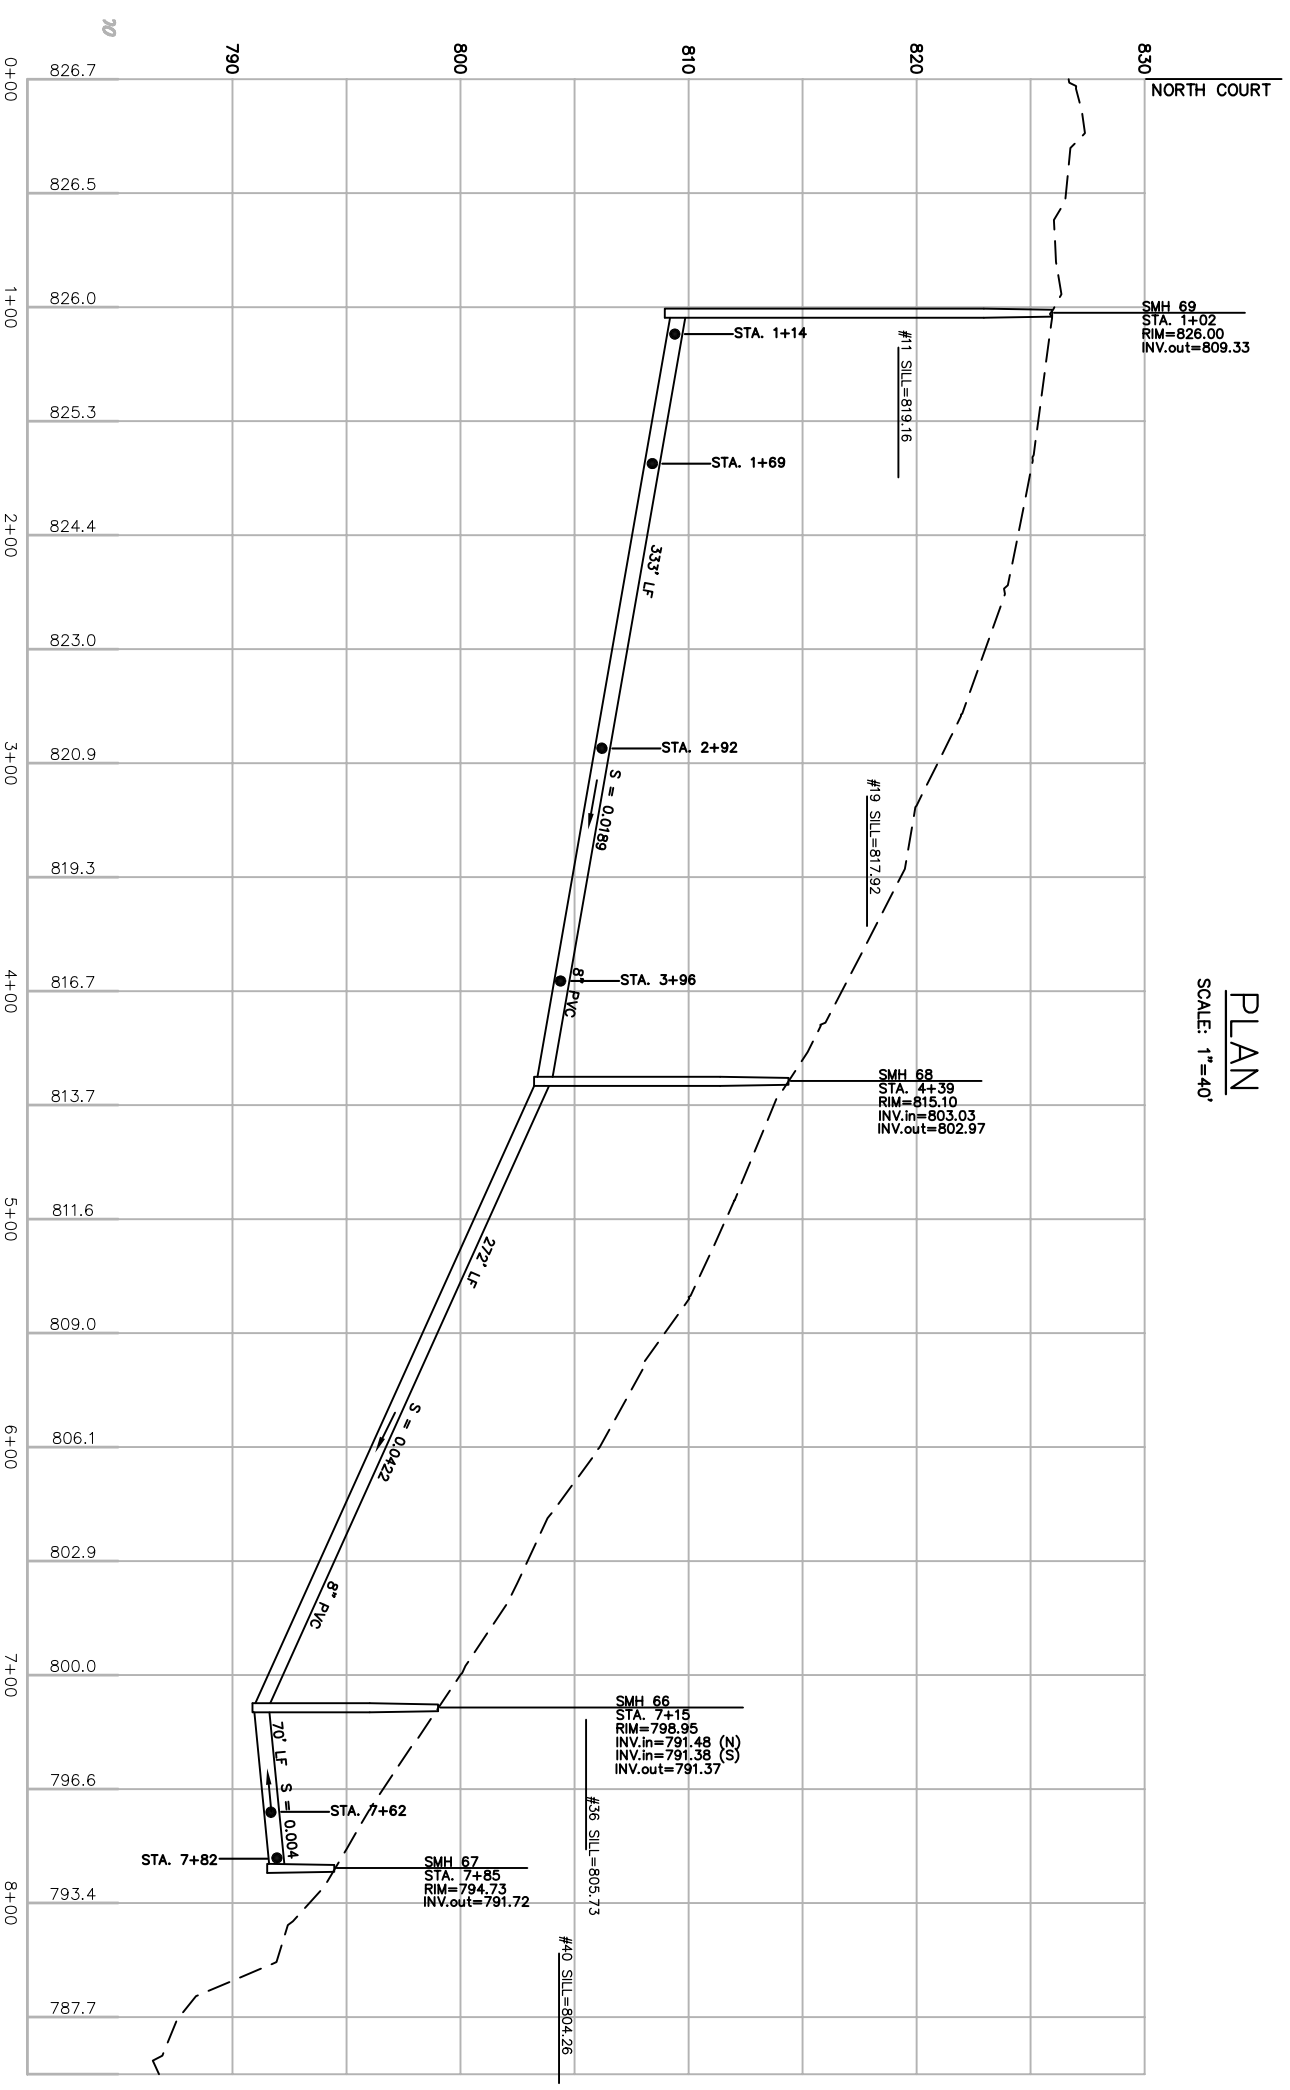

PROFILE
SCALE: 1"=40' HORIZ.
1"=4' VERT.

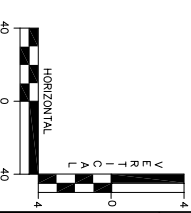

SHEET 1 OF 18
DRAWING NO. 1B

CHERRY VALLEY SEWER DISTRICT
LEICESTER, MASSACHUSETTS
PLAN AND PROFILE
SOUTH STREET
0+00 TO 7+95

HTA Hoyle, Tanner & Associates, Inc.
150 Dow Street • Manchester • New Hampshire 03101
Consulting Engineers

SCALE: AS SHOWN DATE: APRIL 2000 DES. BY: JAH DR. BY: RCP CHKD. BY: NLT

PROJECT NO.	105707	FILE NAME	AB-PF-SOUST
DO NOT SCALE DRAWING	1. AS-BUILTS	C.B. J.H.	J.H. 12/00
REV.	DESCRIPTION	DR. BY	CHKD. BY
		APPR. BY	DATE

AS-BUILT
I HEREBY CERTIFY THAT TO THE BEST OF MY KNOWLEDGE, BASED UPON CONSTRUCTION RECORDS PROVIDED BY THE DESIGNER AND MY OWN FIELD SURVEY AND ALIEN WORK SHOWN ON THIS DRAWING, HAS BEEN COMPLETED AS SHOWN.
HOYLE, TANNER & ASSOCIATES, INC.
SIGNED _____
DATE _____

ENGINEER/ARCHITECT