


PLAN  
SCALE: 1"=40'

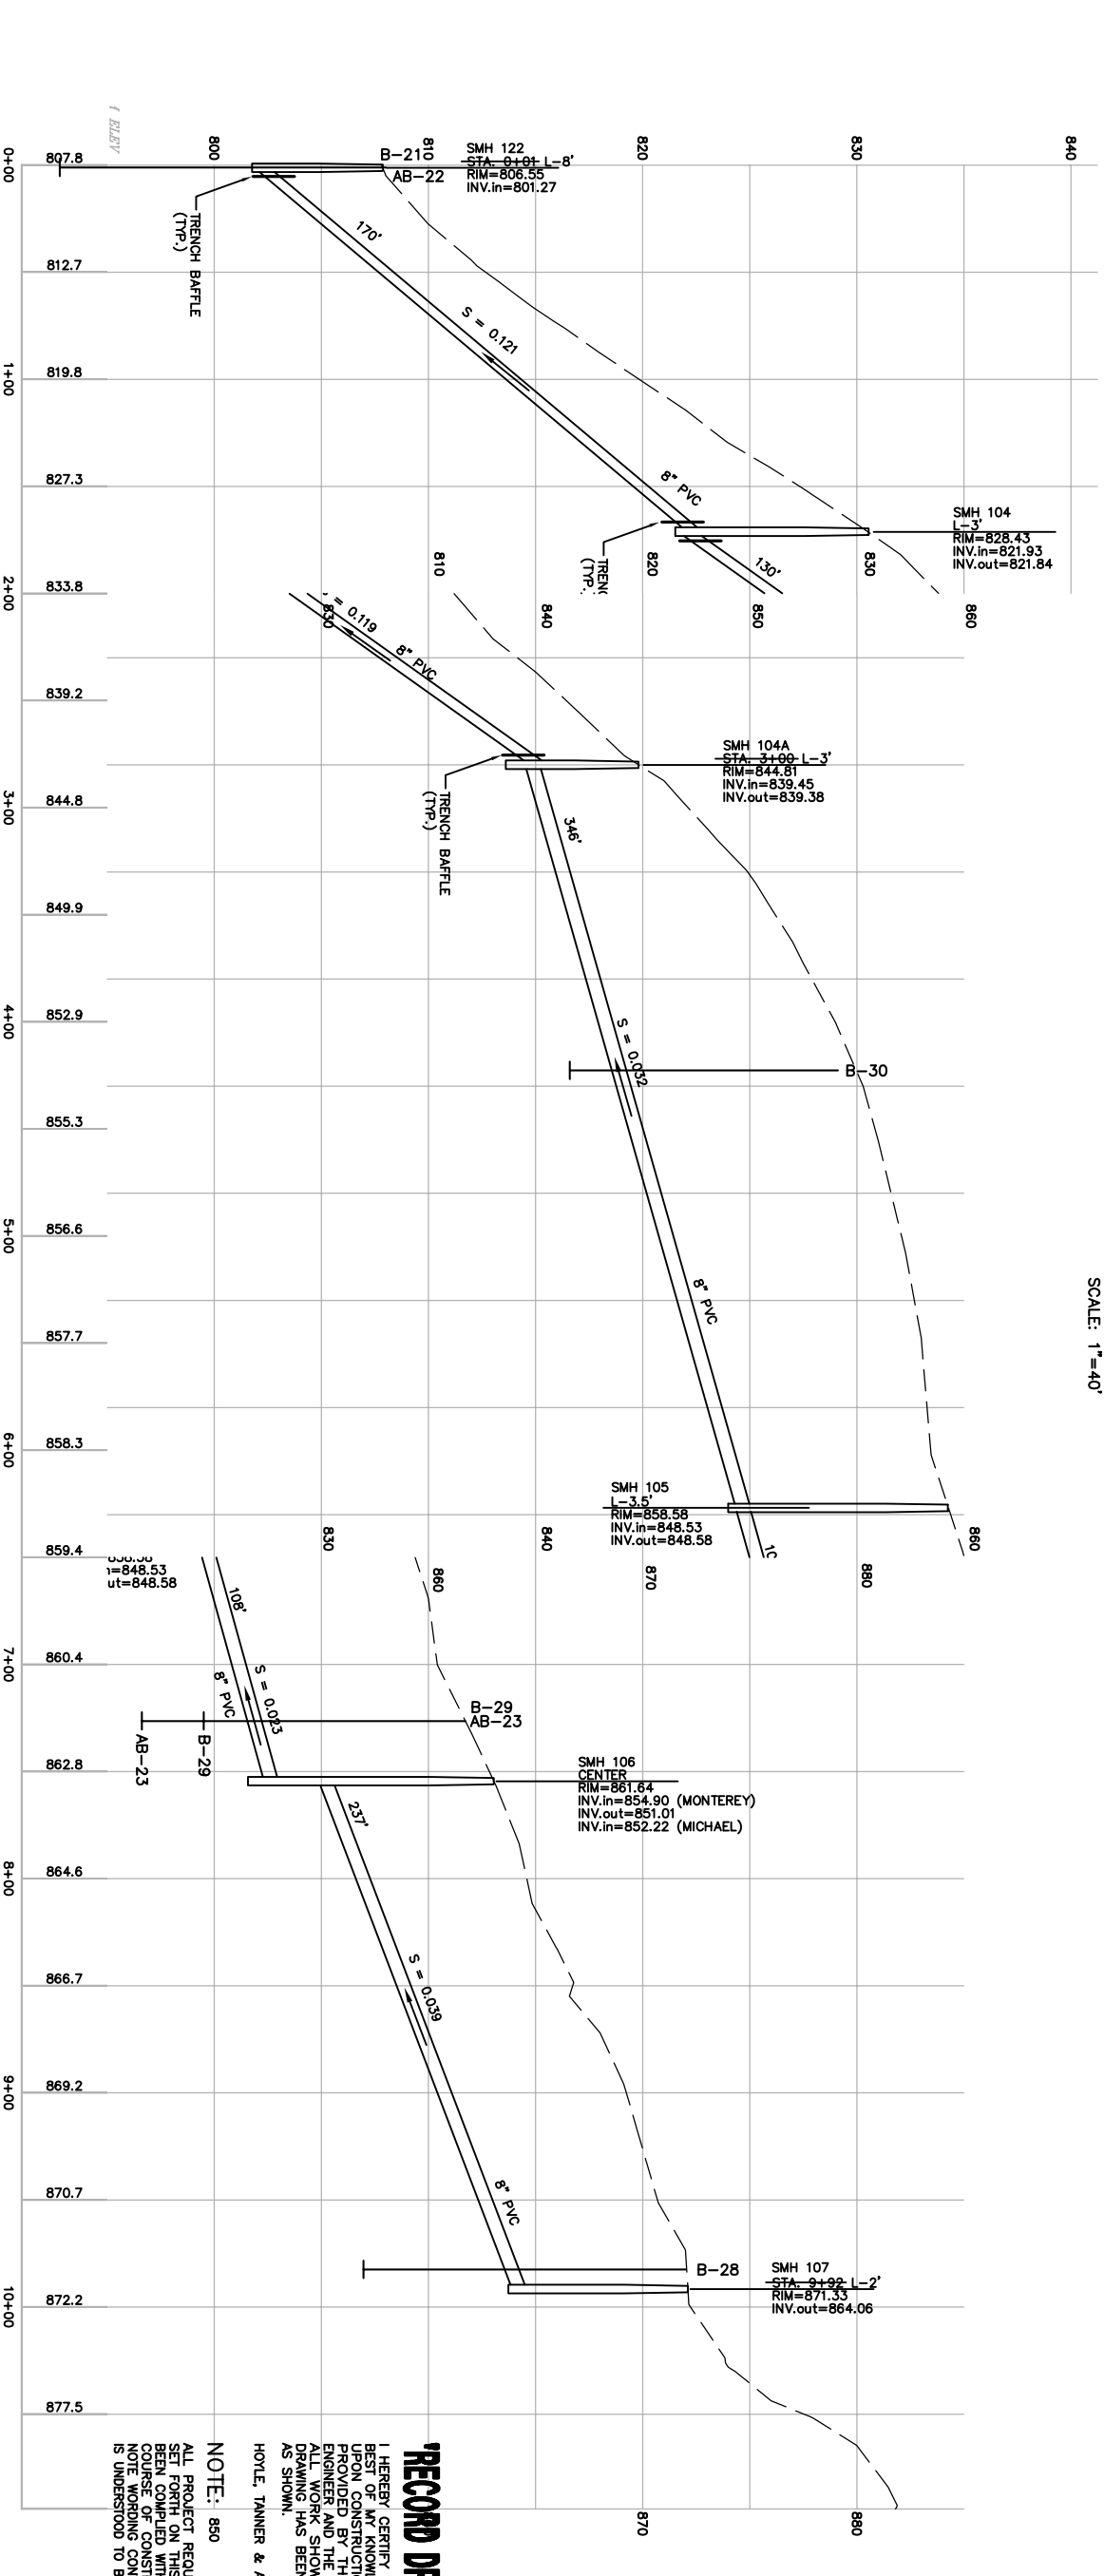


PROFILE  
SCALE: 1"=40' HORIZ.  
1"=4' VERT.

**RECORD DRAWING**

I HEREBY CERTIFY THAT TO THE BEST OF MY KNOWLEDGE AND BELIEF, THE INFORMATION PROVIDED BY THE RESIDENT ENGINEER AND THE CONTRACTOR, ALL WORK SHOWN ON THIS DRAWING HAS BEEN COMPLETED AS SHOWN.

HOYLE, TANNER & ASSOCIATES, INC.

NOTE: 850  
ALL PROJECT REQUIREMENTS AS SET FORTH ON THIS SHEET HAVE BEEN COMPLETED WITH DURING THE COURSE OF CONSTRUCTION, AND THE INFORMATION IS UNDERSTOOD TO BE PASSED ON TO BE PASSED ON.

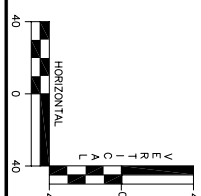

DRAWING NO. <b>28</b>	CHERRY VALLEY SEWER DISTRICT LEICESTER, MASSACHUSETTS		<b>Hoyle, Tanner &amp; Associates, Inc.</b> 150 Dow Street • Manchester • New Hampshire 03101 Consulting Engineers			PROJECT NO. 105709	ENGINEER/ARCHITECT
	PLAN AND PROFILE		SCALE: AS SHOWN			FILE NAME ABPROF-27	
SHEET 28 OF 38	MONTEREY DRIVE STA. 0+00 TO 12+00		DATE: APRIL 2001	DES. BY JAH	DR. BY CAB/RCP	CHKD. BY NLT	1. RECORD DRAWING C.B. W.C. W.C. 10/02 DR. CHD. APPD. DATE