



HENSHAW STREET

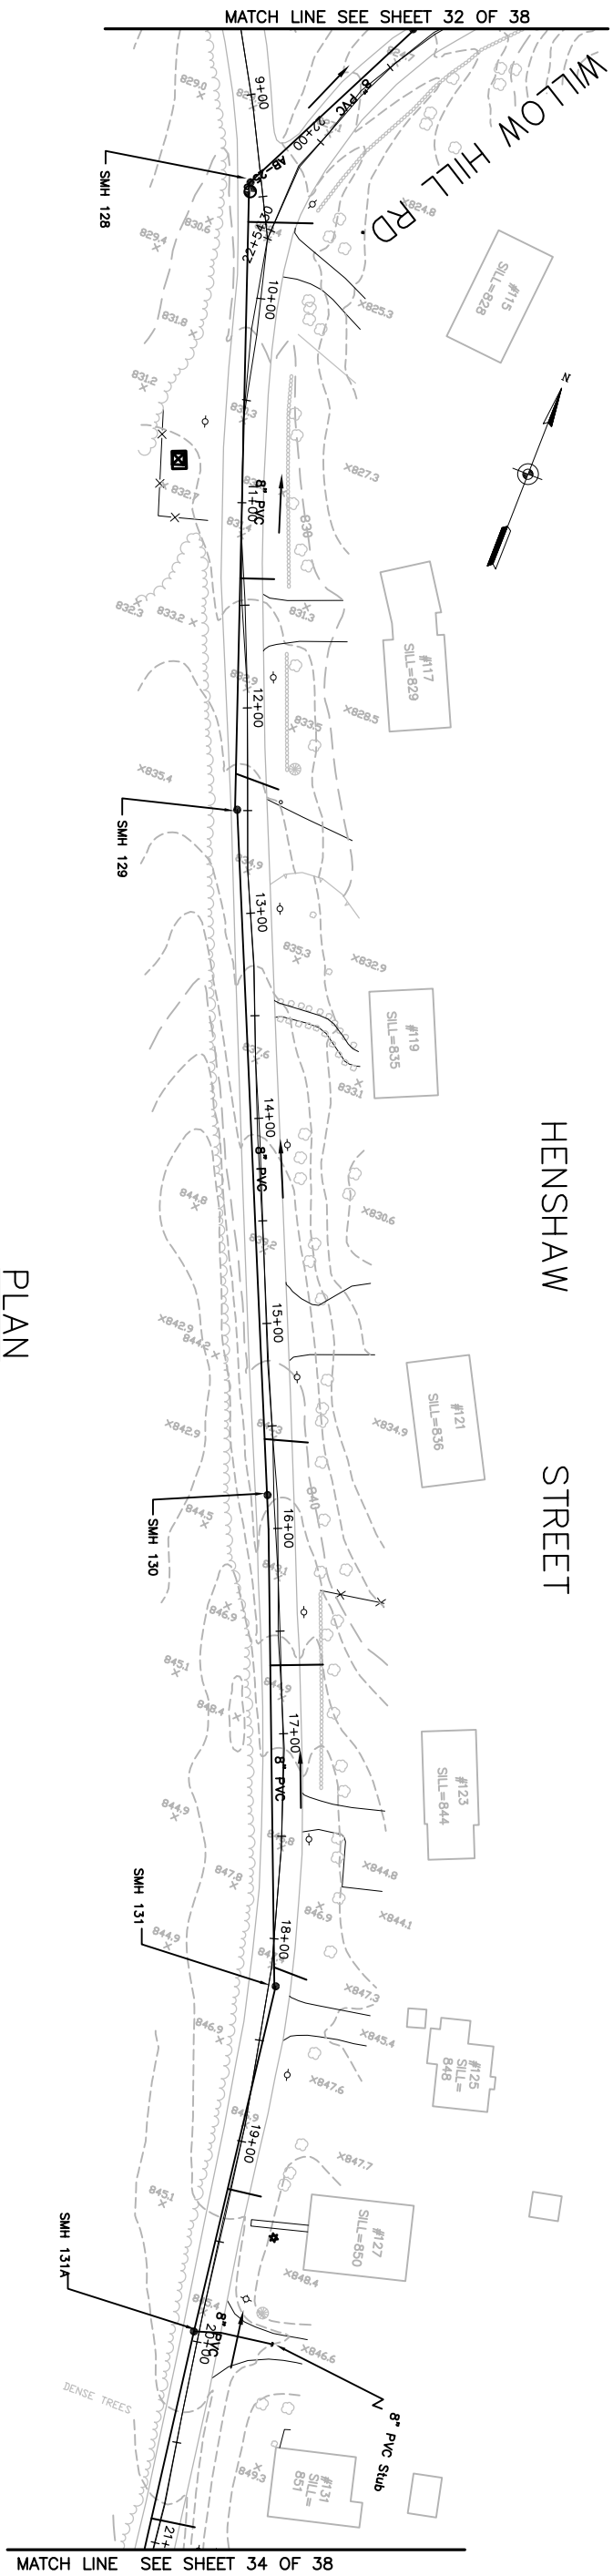

PLAN
SCALE: 1"=40'

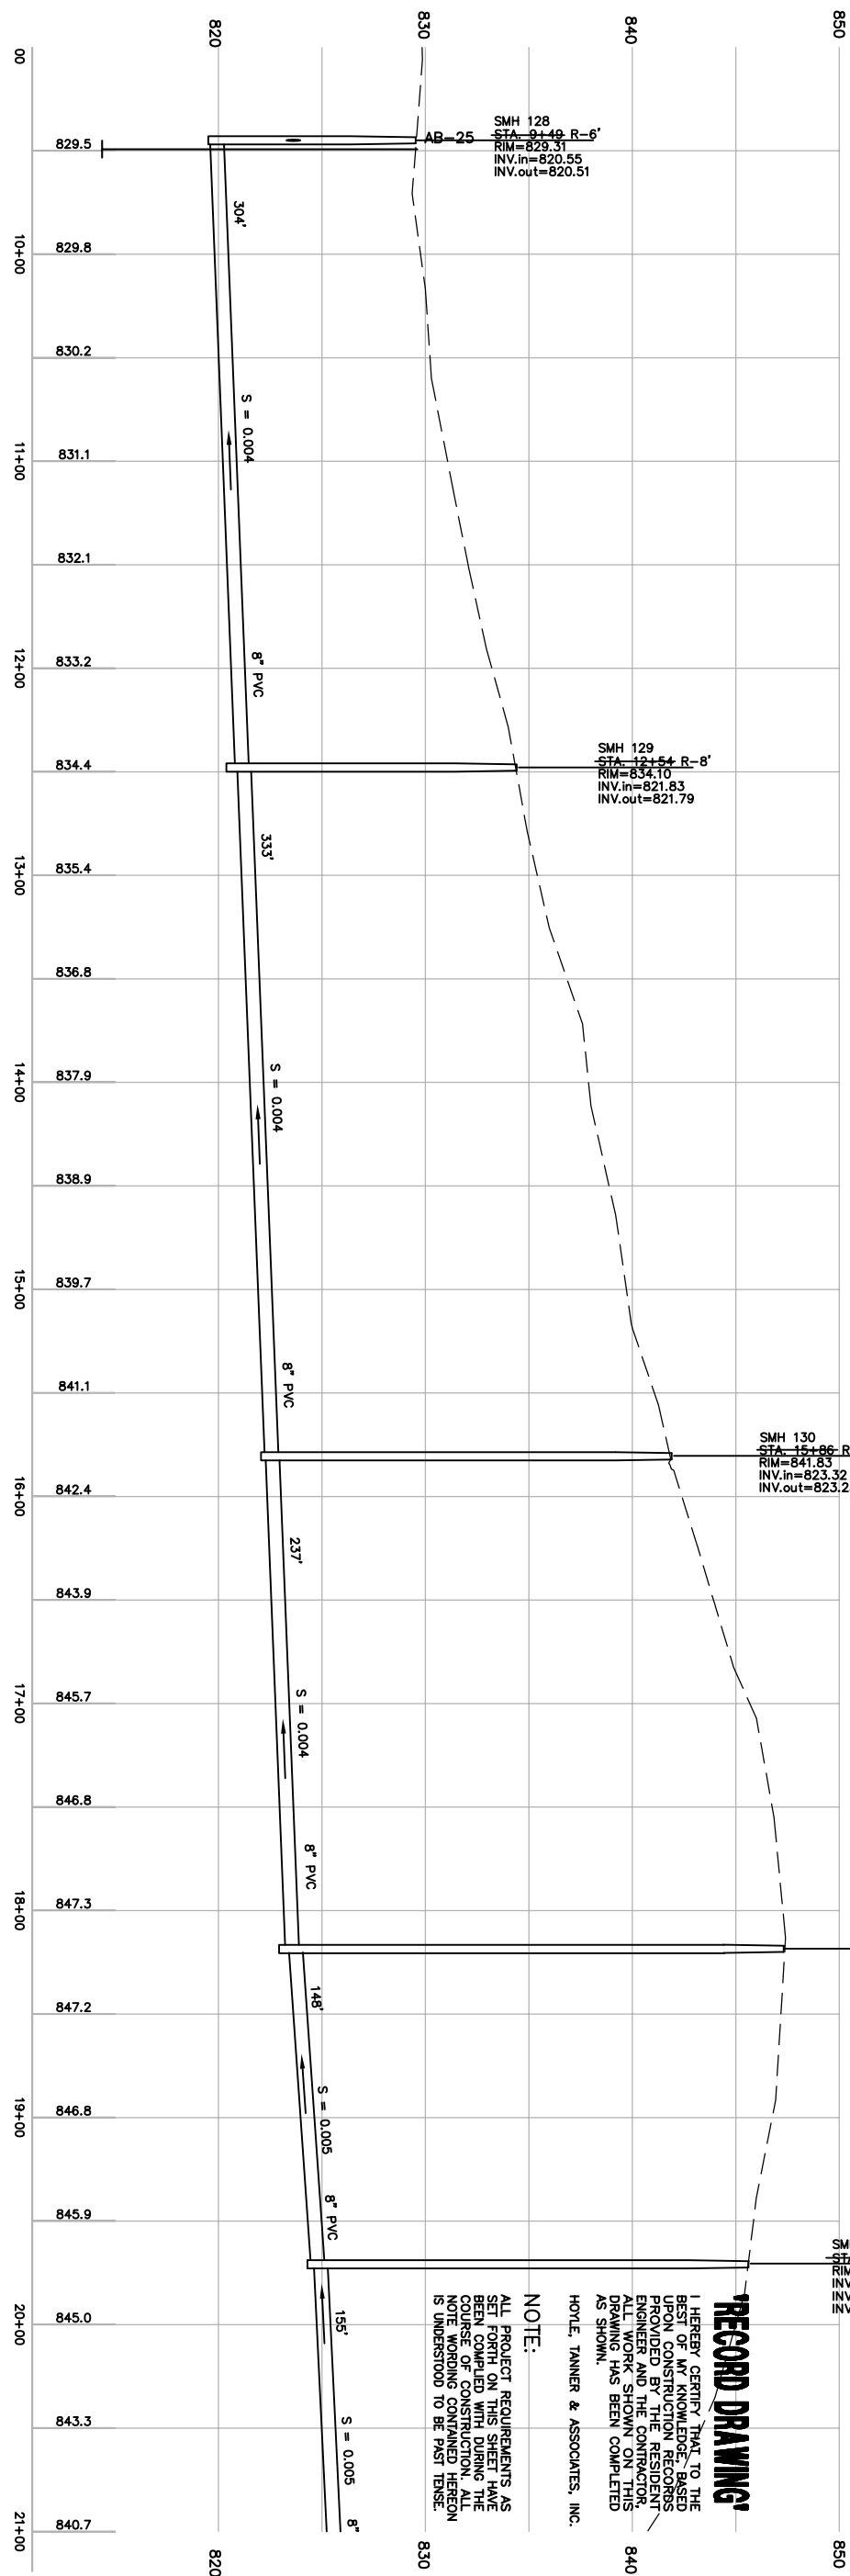


NOTE:
ALL PROJECT REQUIREMENTS AS SET FORTH IN THE SPECIFICATIONS HAVE BEEN COMPLIED WITH DURING THE COURSE OF CONSTRUCTION. ALL NOTE WORDING CONTAINED HEREON IS UNDERSTOOD TO BE PAST TENSE.

RECORD DRAWING!

I HEREBY CERTIFY THAT TO THE BEST OF MY KNOWLEDGE, BASED UPON CONSTRUCTION RECORDS PROVIDED BY THE RESIDENT, ENGINEER AND THE CONTRACTOR, ALL WORK SHOWN ON THIS DRAWING HAS BEEN COMPLETED AS SHOWN.
HOYLE, TANNER & ASSOCIATES, INC.

PROFILE
SCALE: 1"=40' HORIZ.
1"=4' VERT.

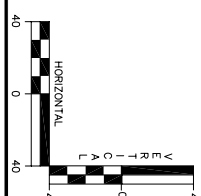

CHERRY VALLEY SEWER DISTRICT LEICESTER, MASSACHUSETTS PLAN AND PROFILE HENSHAW STREET		HTA Hoyle, Tanner & Associates, Inc. 150 Dow Street • Manchester • New Hampshire 03101 Consulting Engineers		PROJECT NO. 105709		FILE NAME ABPROF-33		ENGINEER/ARCHITECT	
DRAWING NO. 33		SCALE: AS SHOWN		DATE: APRIL 2001		DES. BY JAH		DR. BY CAB/RCP	
SHEET 33 OF 38		CHKD. BY NLT		DO NOT SCALE DRAWING		1. RECORD DRAWING		C.B. W.C. W.C. 10/02	
						REV. DESCRIPTION		DR. BY CHKD. BY APPD. BY DATE	