


PLAN
SCALE: 1"=40'

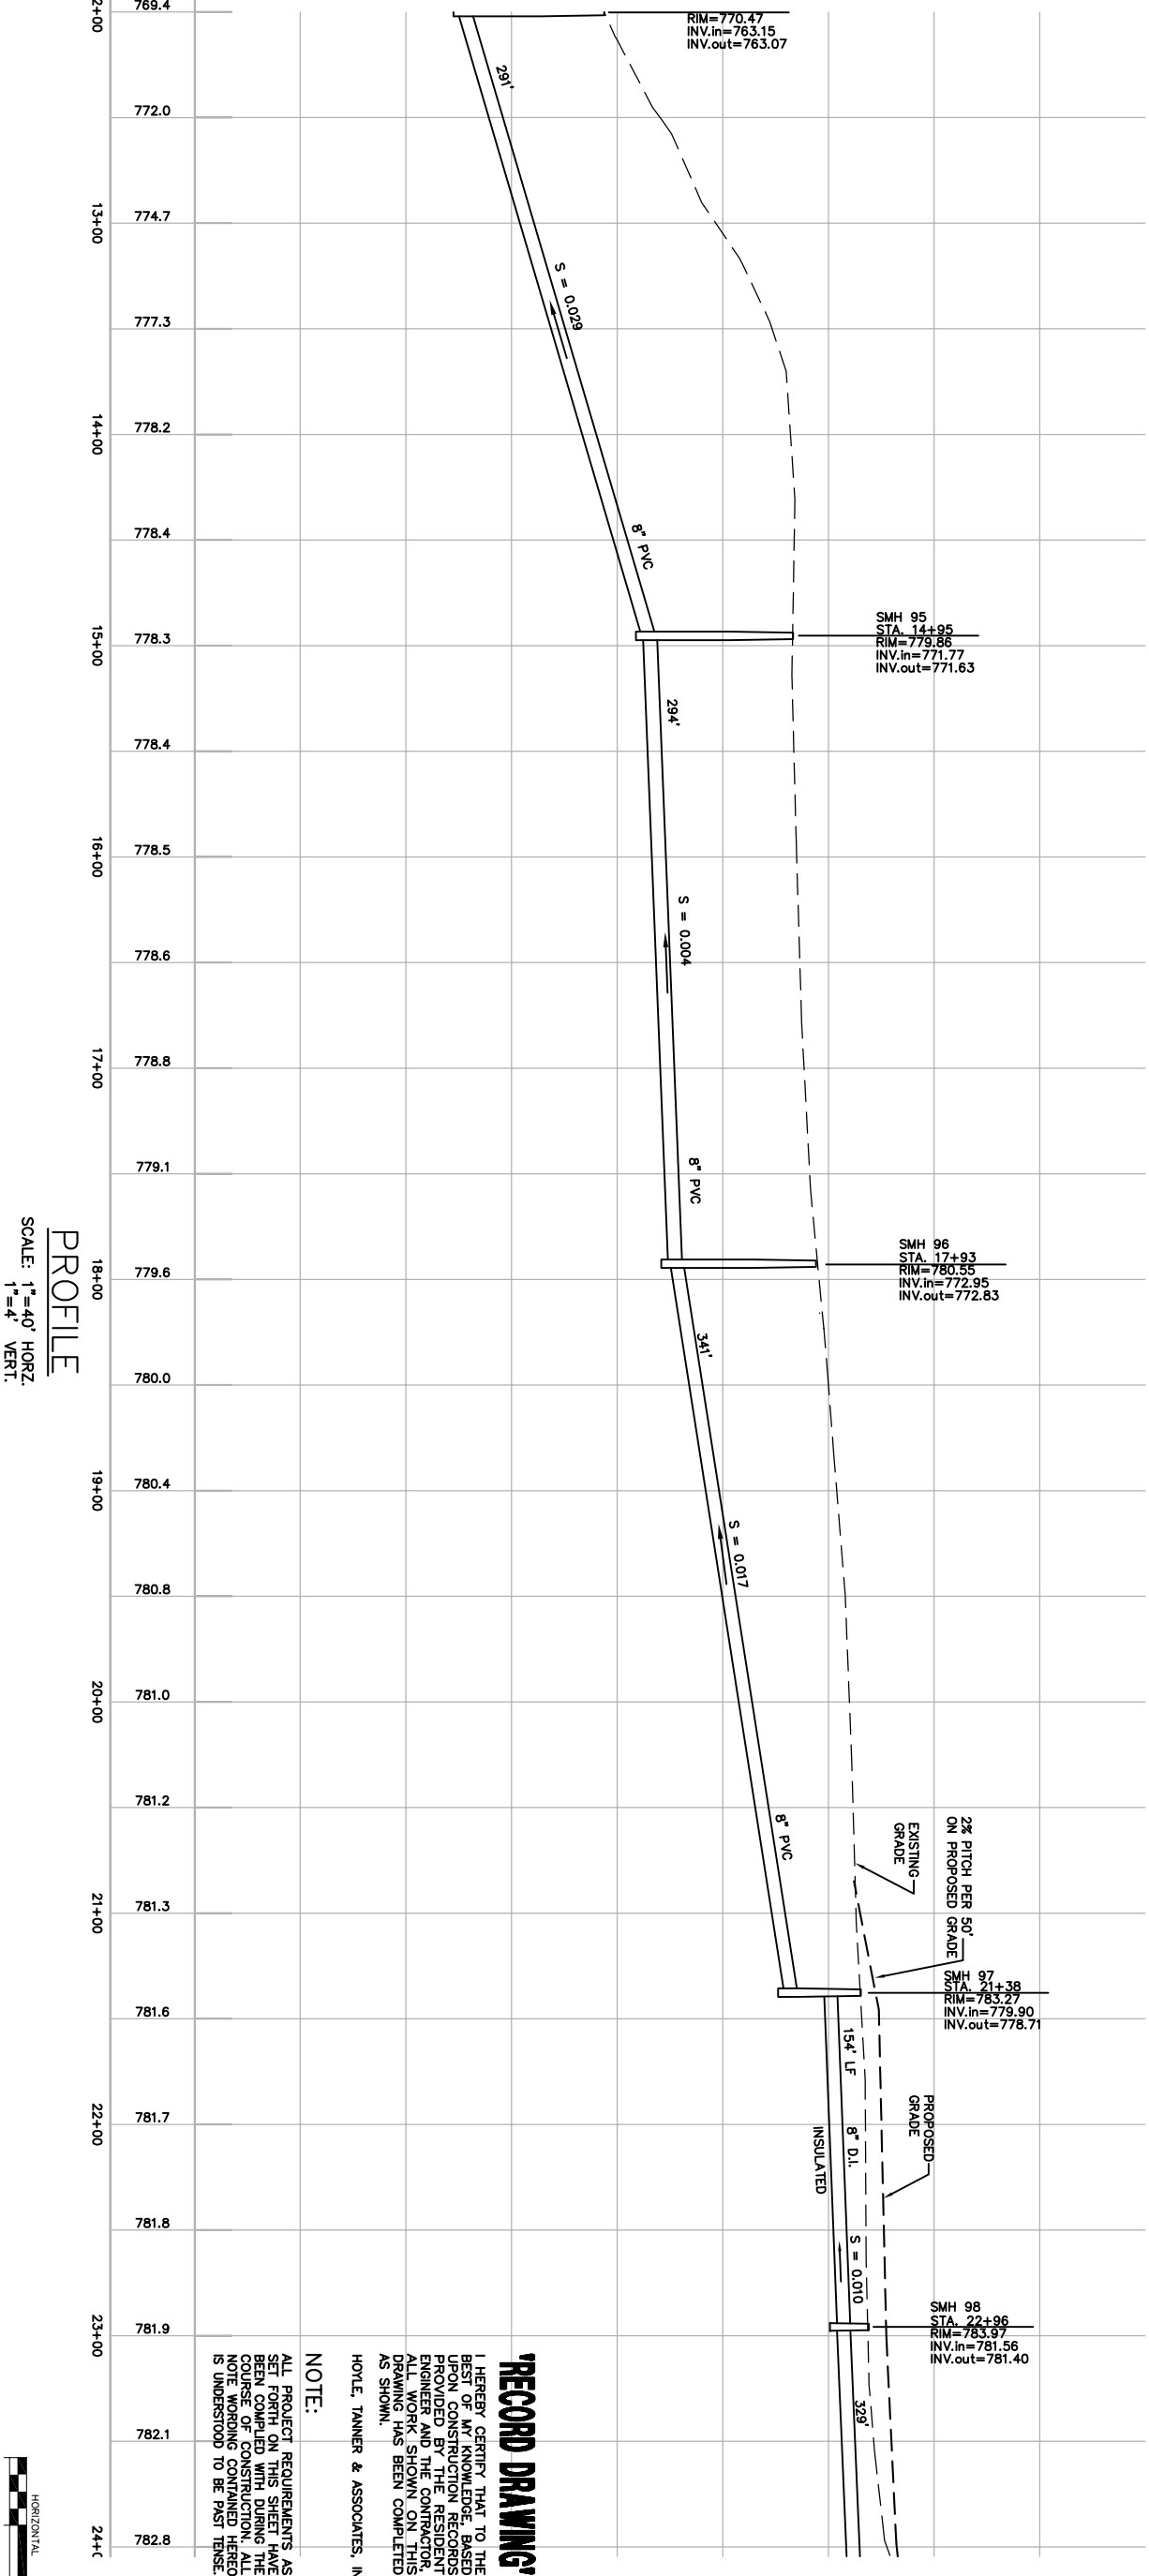

PROFILE
SCALE: 1"=40' HORZ.
1"=4' VERT.

RECORD DRAWING

I HEREBY CERTIFY THAT TO THE BEST OF MY KNOWLEDGE, BASED ON INSPECTION AND RECORDS PROVIDED BY THE CONTRACTOR, ALL WORK SHOWN ON THIS DRAWING HAS BEEN COMPLETED AS SHOWN.

HOYLE, TANNER & ASSOCIATES, INC.

NOTE:

ALL PROJECT REQUIREMENTS AS SET FORTH ON THIS SHEET HAVE BEEN COMPLIED WITH DURING THE COURSE OF CONSTRUCTION. ALL NOTE WORKING CONTAINED HEREON IS UNDERSTOOD TO BE FIRST TENSE.

DRAWING NO. 26	CHERRY VALLEY SEWER DISTRICT LEICESTER, MASSACHUSETTS		PROJECT NO. 105709		ENGINEER/ARCHITECT		
	PLAN AND PROFILE		FILE NAME ABPROF-25		C.B. W.C. W.C. 10/02		
CHAPEL STREET STA. 12+00 TO 24+00		SCALE: AS SHOWN		DATE: APRIL 2001		REV. DESCRIPTION	
HOYLE, TANNER & ASSOCIATES, INC.		H&A Hoyle, Tanner & Associates, Inc. 150 Dow Street • Manchester • New Hampshire 03101 Consulting Engineers		DES. BY JAH		DR. BY CAB/RCP	
NOTE:		SCALE: AS SHOWN		DATE: APRIL 2001		CHKD. BY NLT	
CHERRY VALLEY SEWER DISTRICT LEICESTER, MASSACHUSETTS		PROJECT NO. 105709		FILE NAME ABPROF-25		DO NOT SCALE DRAWING	
CHAPEL STREET STA. 12+00 TO 24+00		SCALE: AS SHOWN		DATE: APRIL 2001		1. RECORD DRAWING	
HOYLE, TANNER & ASSOCIATES, INC.		H&A Hoyle, Tanner & Associates, Inc. 150 Dow Street • Manchester • New Hampshire 03101 Consulting Engineers		DES. BY JAH		DR. BY CAB/RCP	
NOTE:		SCALE: AS SHOWN		DATE: APRIL 2001		CHKD. BY NLT	