



PLAN
SCALE: 1"=40'

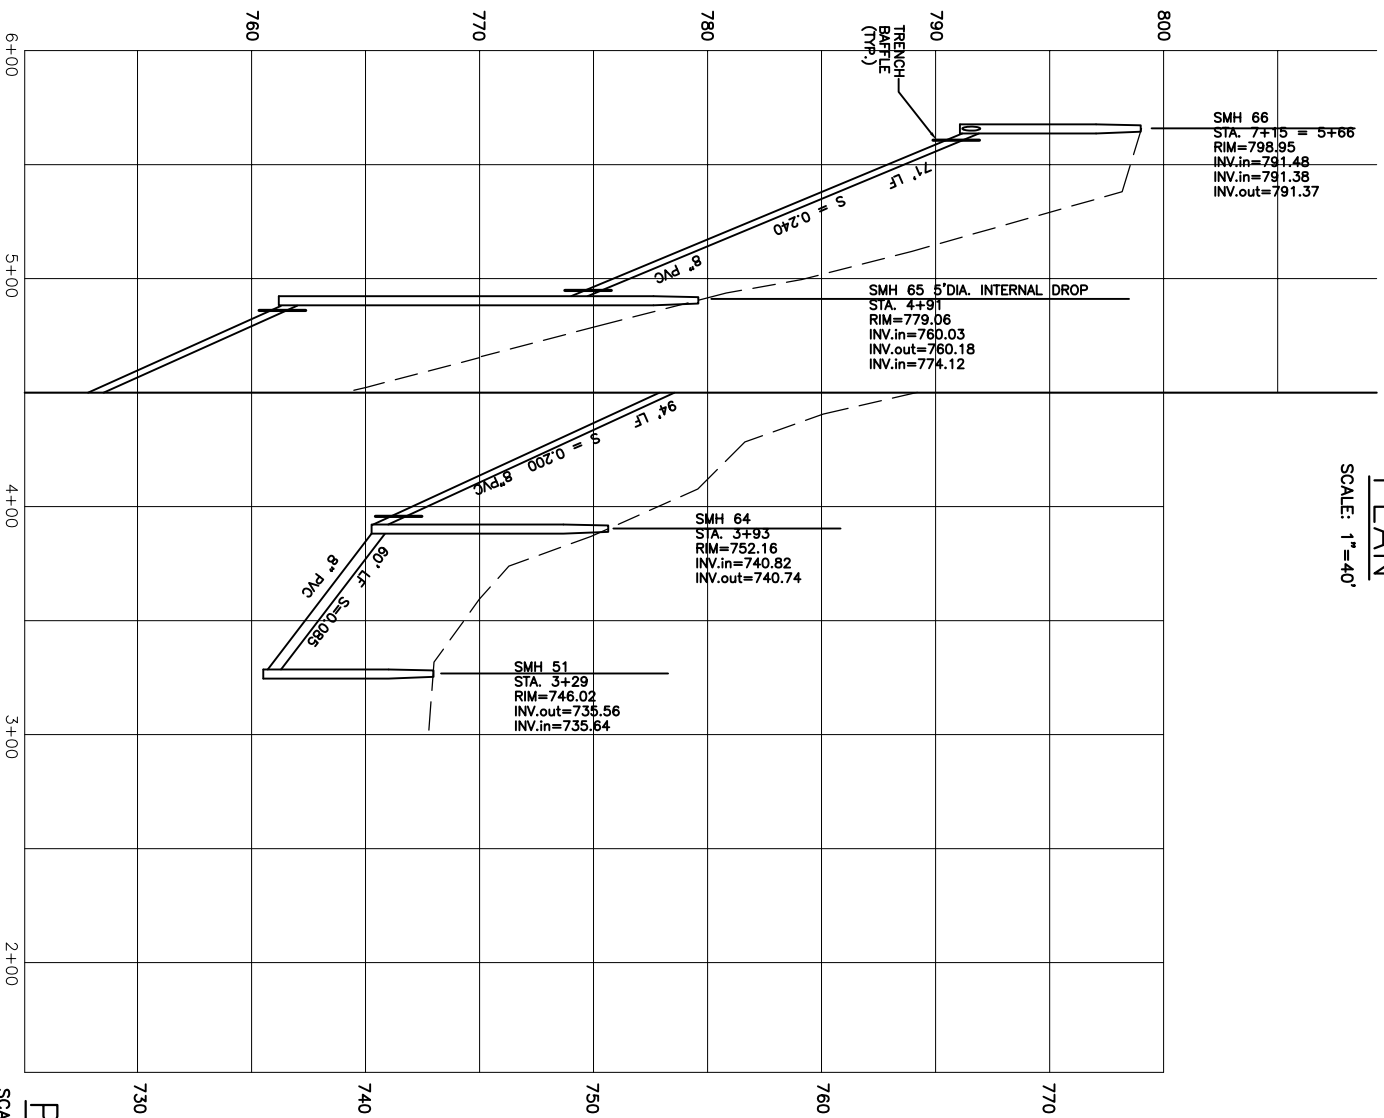

PROFILE
SCALE: 1"=40' HORZ.
1"=4' VERT.

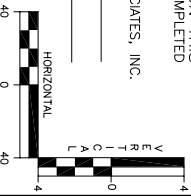

'AS-BUILT'

I HEREBY CERTIFY THAT THE DESIGN AND CONSTRUCTION OF THE SEWER LINE SHOWN ON THIS DRAWING WAS PROVIDED BY THE RESIDENT ENGINEER AND THE CONTRACTOR. ALL WORK SHOWN ON THIS DRAWING HAS BEEN COMPLETED AS SHOWN.

HOYLE, TANNER & ASSOCIATES, INC.
SIGNED _____
DATE _____

CHERRY VALLEY SEWER DISTRICT
LEICESTER, MASSACHUSETTS
PLAN AND PROFILE
EASEMENT/SOUTH COURT
0+00 TO 8+00

HTA Hoyle, Tanner & Associates, Inc.
150 Dow Street • Manchester • New Hampshire 03101
Consulting Engineers

SCALE: AS SHOWN DATE: APRIL 2000 DES. BY: JAH DR. BY: RCP CHKD. BY: NLT

PROJECT NO.	105707
FILE NAME	AB-PF-ESSOUCT
DO NOT SCALE DRAWING	
REV.	DESCRIPTION
1.	AS-BUILTS

C.B. J.H. J.H. 12/00
DR. BY: CHKD. BY: APPD. BY: DATE

DRAWING NO. **2B**
SHEET 2 OF 28

ENGINEER/ARCHITECT